

PROJECT:
**PROPOSED GOVERNMENT AYURVEDIC
MEDICAL COLLEGE AT VARANASI**

NO. TITLE:
ACADEMIC BLOCK

DRG. TITLE:
SECOND FLOOR PLAN

DATE:
OCT 10

DRG. NO.:
VAMC/ARCH/ACA/ST/03

SCALE:
NTS

SHEET No.:
03

CONSTRUCTION AGENT:

FOR PROVISIONING:

(ARCHITECT)


CONSULTING ARCHITECT:

PRODESIGNERS
Prashant K. Singh

Address:
15th Floor, New India Assurance Building, Lucknow-226014
Office:
15th Floor, New India Assurance Building, Lucknow-226014
Email: prodesigners@gmail.com
Website: www.prodesigners.com



PRODESIGNERS
15th Floor, New India Assurance Building
Lucknow-226014
Phone: 0522-215153

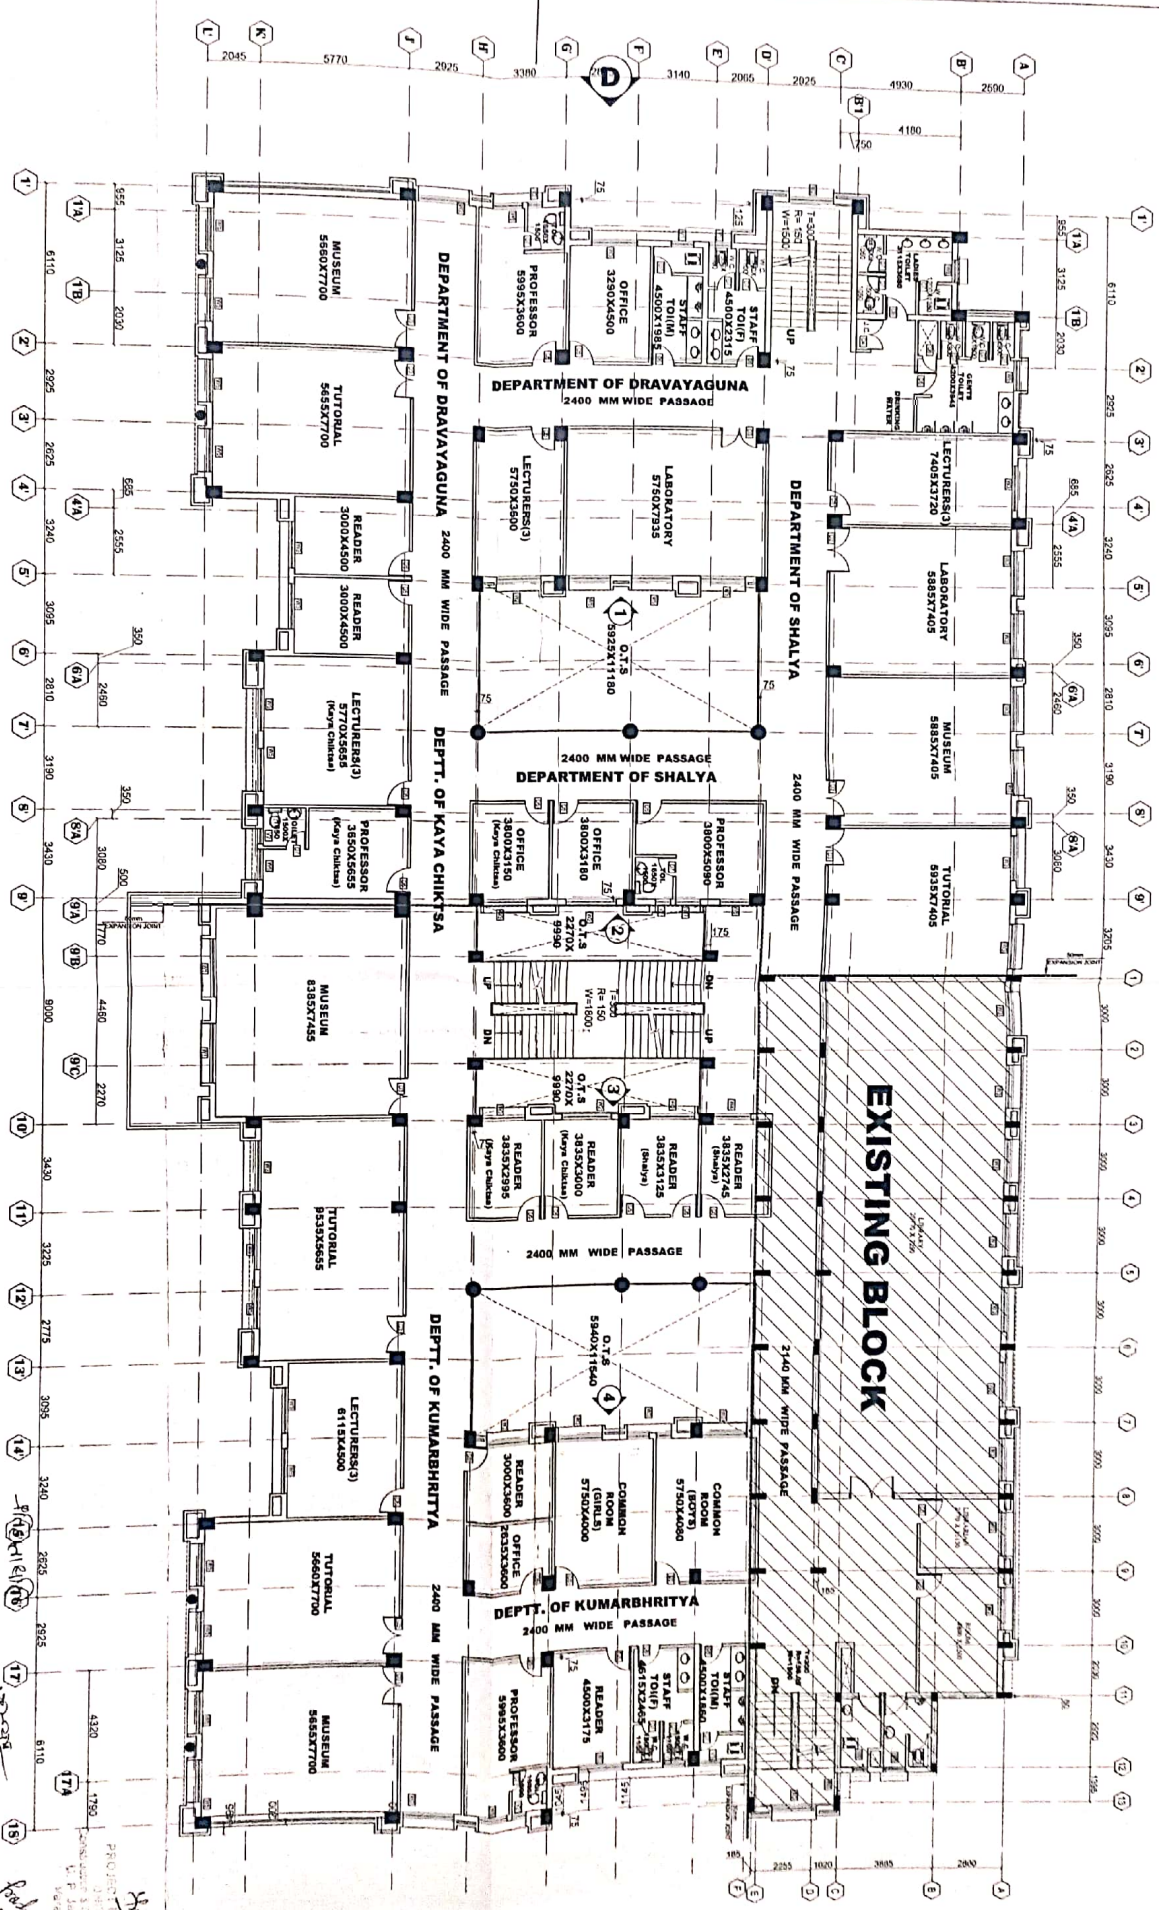

**PROPOSED GOVERNMENT AYURVEDIC
MEDICAL COLLEGE AT VARANASI**

ACADEMIC BLOCK

OCT 10

NIS

CONSTRUCTION AGENT

CONSTRUCTION AGENT


CONSTRUCTION AGENT


PRODESIGNERS

Prashant K. Singh



Address: 1st Floor, New India Building, Lucknow-226011
Office: 1st Floor, New India Building, Lucknow-226011
Email: prashantk.singh@prodesigners.com, prashantk.singh@prodesigners.com
Mobile: 9953244511, 9953244511

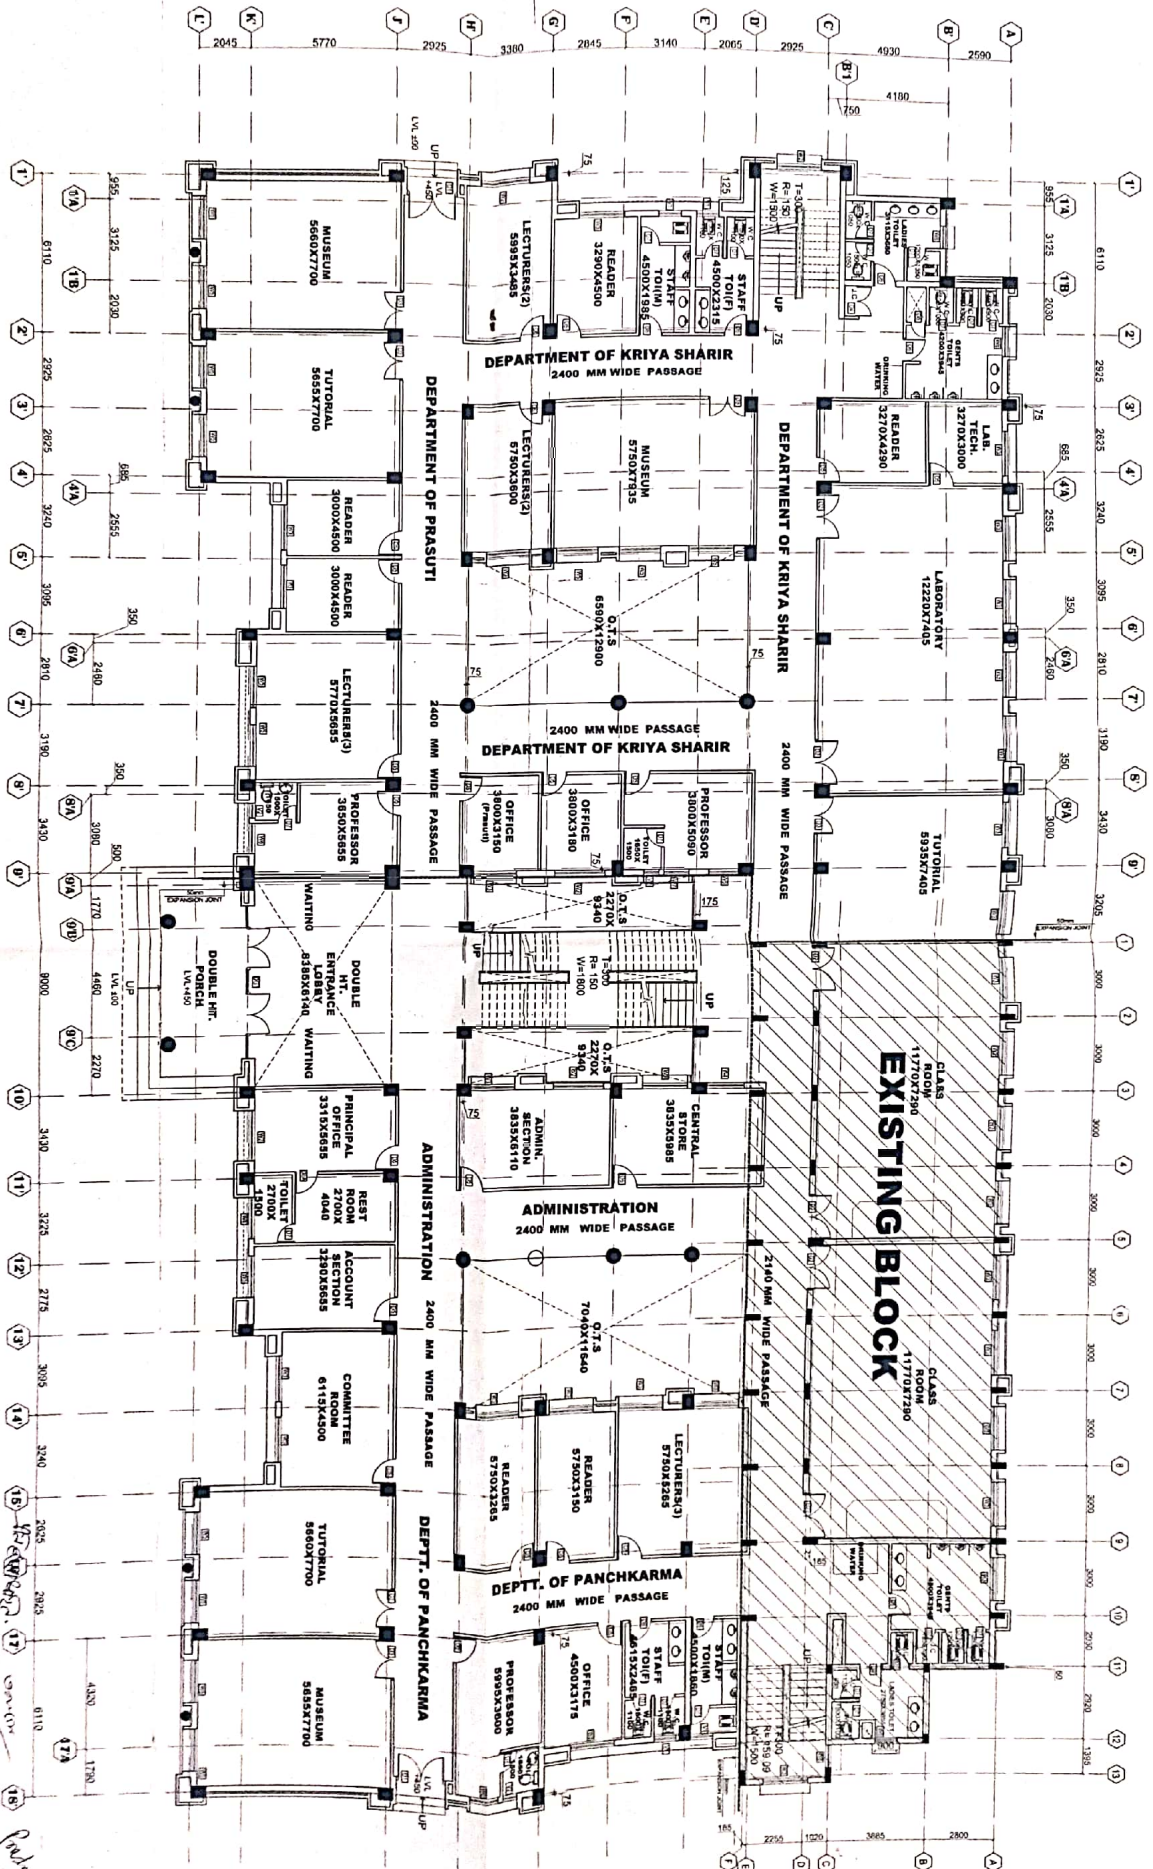

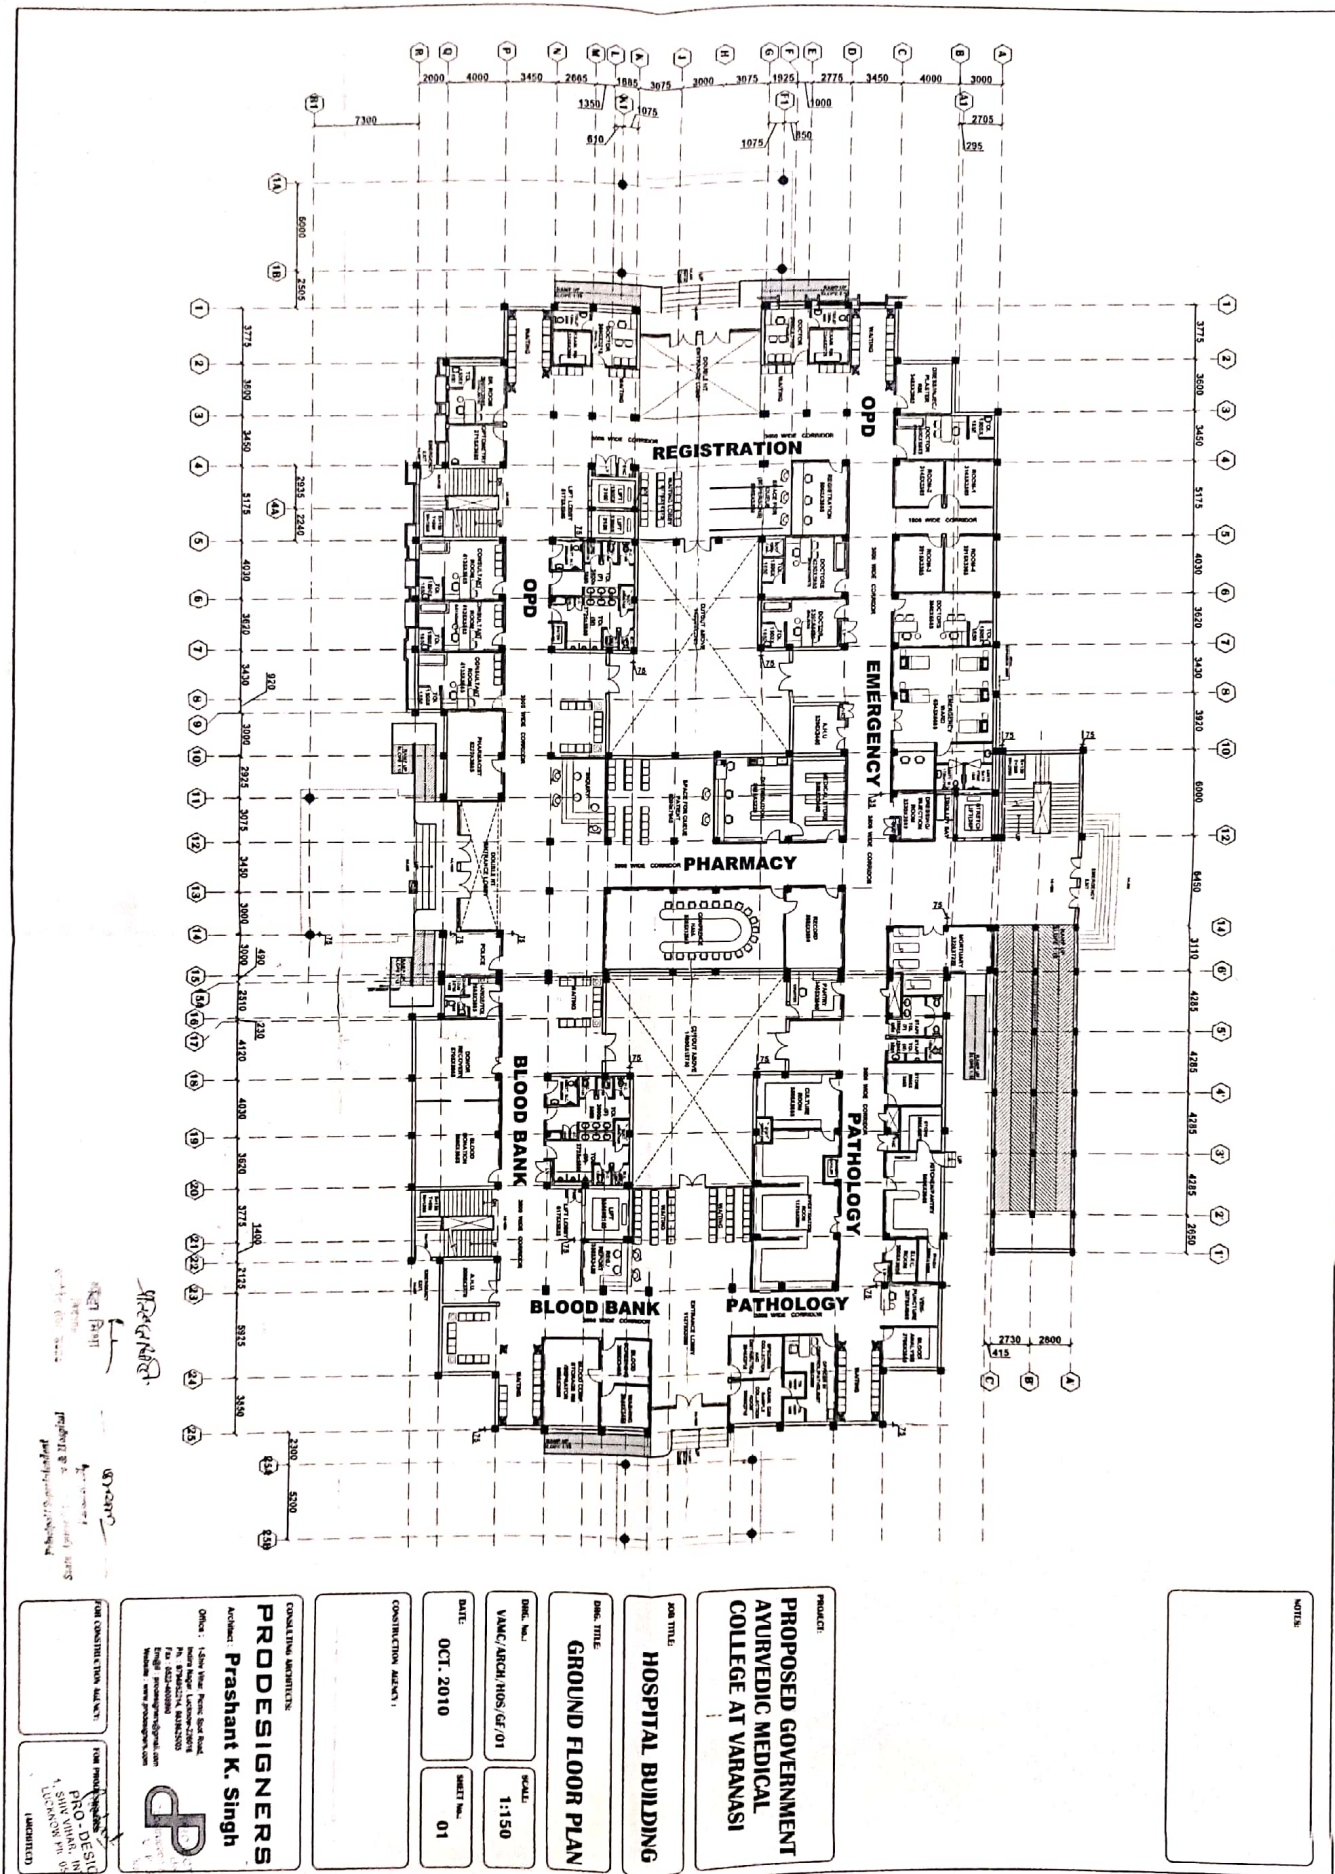

**PROPOSED GOVERNMENT AYURVEDIC
MEDICAL COLLEGE AT VARANASI**

**ACADEMIC BLOCK
THIRD FLOOR PLAN**

DATE: OCT '10

PROJECT NO: 04


CONSTRUCTION AGENT


FOR CONSTRUCTION AGENT

FOR PROPOSAL

CONSULTING ENGINEER


PRODESIGNERS
Prashant K. Singh
Office: 1st Floor, 1st Block, 1st Floor, Varanasi - 221001
Phone: 0522-2222222, 0522-2222222
Email: prashantk.singh@prodesigners.com

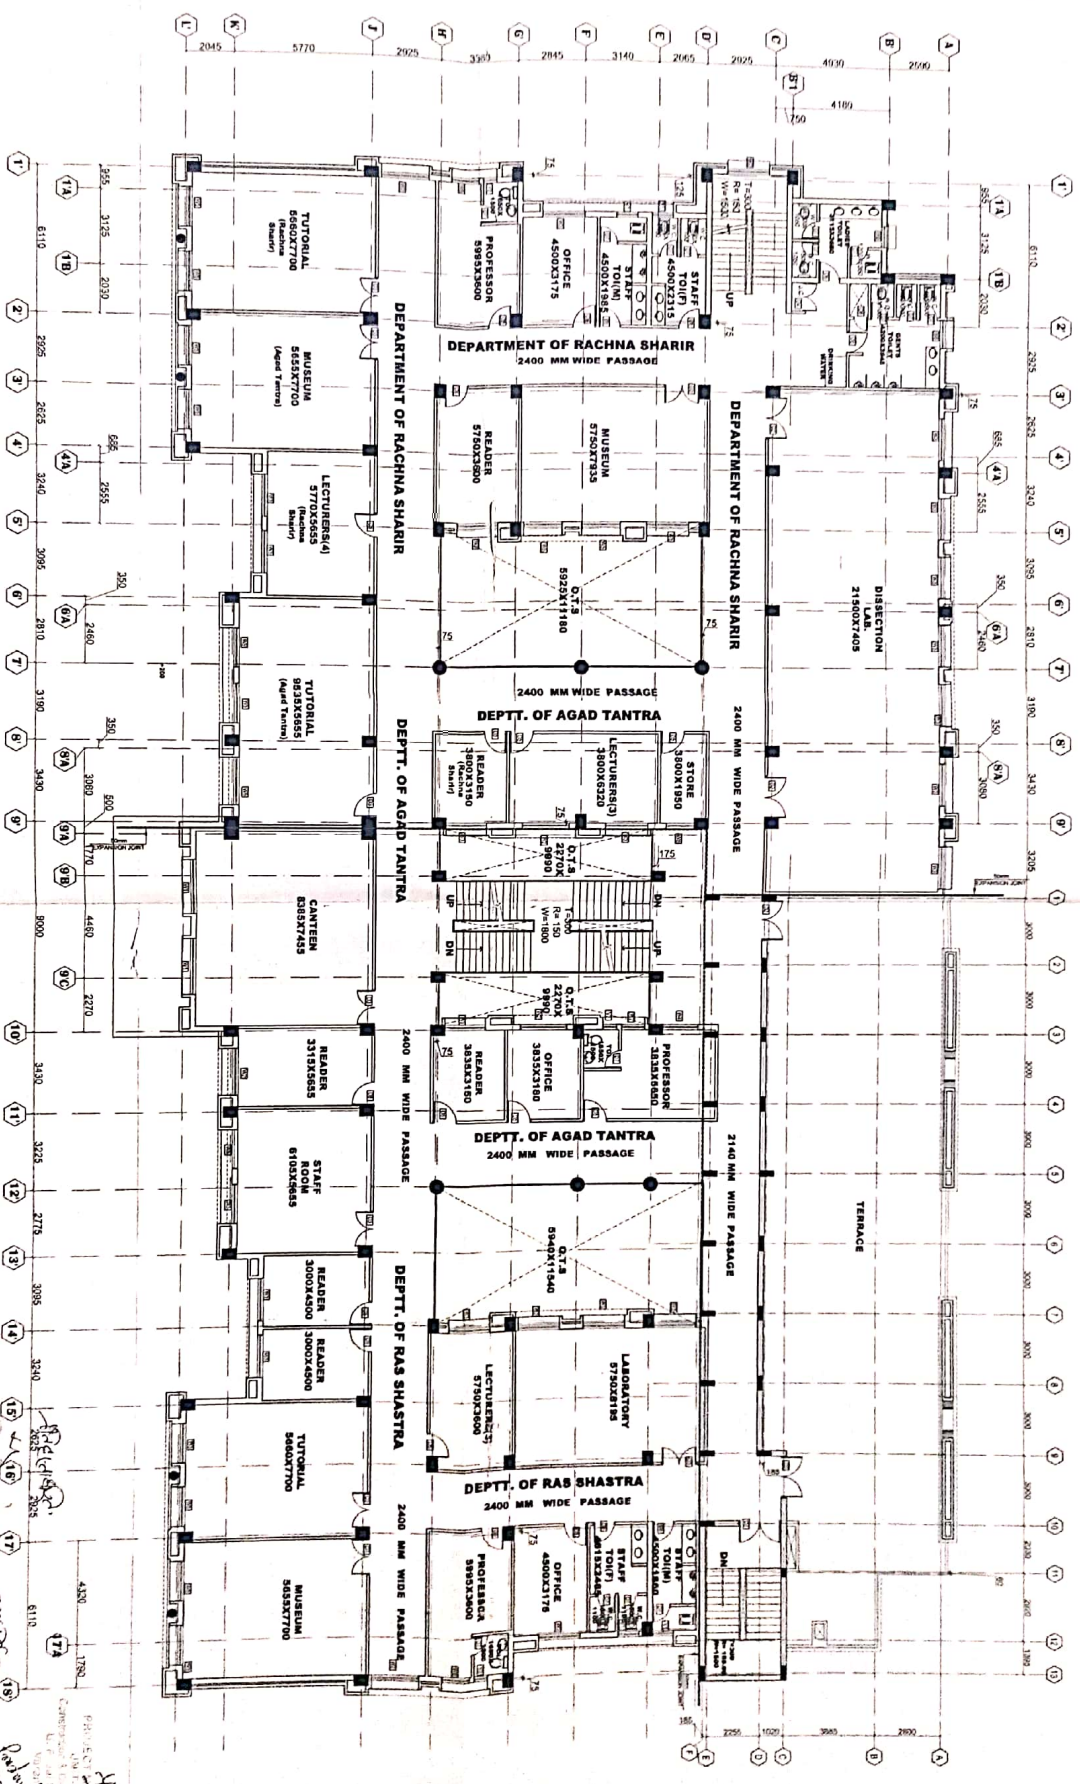

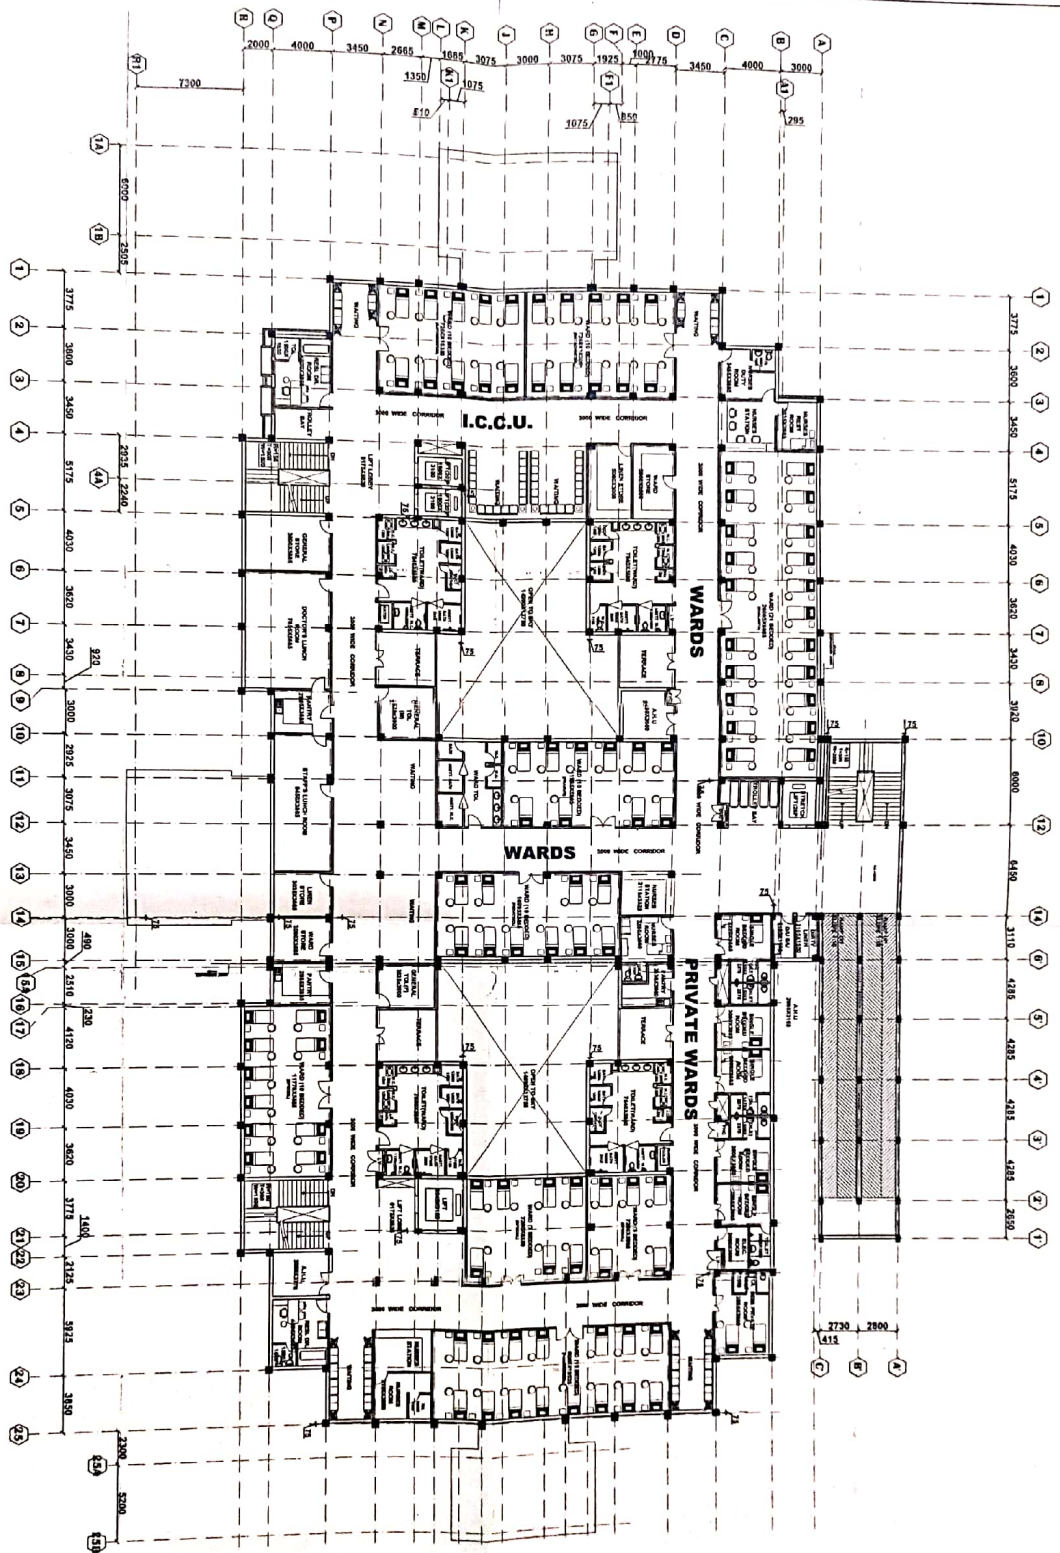

Original
Sheets Approved by: *[Signature]*
14/04/2010

PROPOSED GOVERNMENT AYURVEDIC MEDICAL COLLEGE AT VARANASI	
HOSPITAL BUILDING	
THIRD FLOOR PLAN	
DATE: OCT. 2010	SCALE: 1:150
CONSTRUCTION AGENT:	
CONSULTING ARCHITECT:	
PRODESIGNERS Prashant K. Singh	
Office: SANI Vihar, Post: Sani Road, Varanasi-221005 Tel: 0522-400000 Email: prashantk.singh@gmail.com Website: www.prodesigners.in	
FOR PRODESIGNERS PRO-DESIGNERS SANI VIHAR, LUCKNOW PIN-226001	

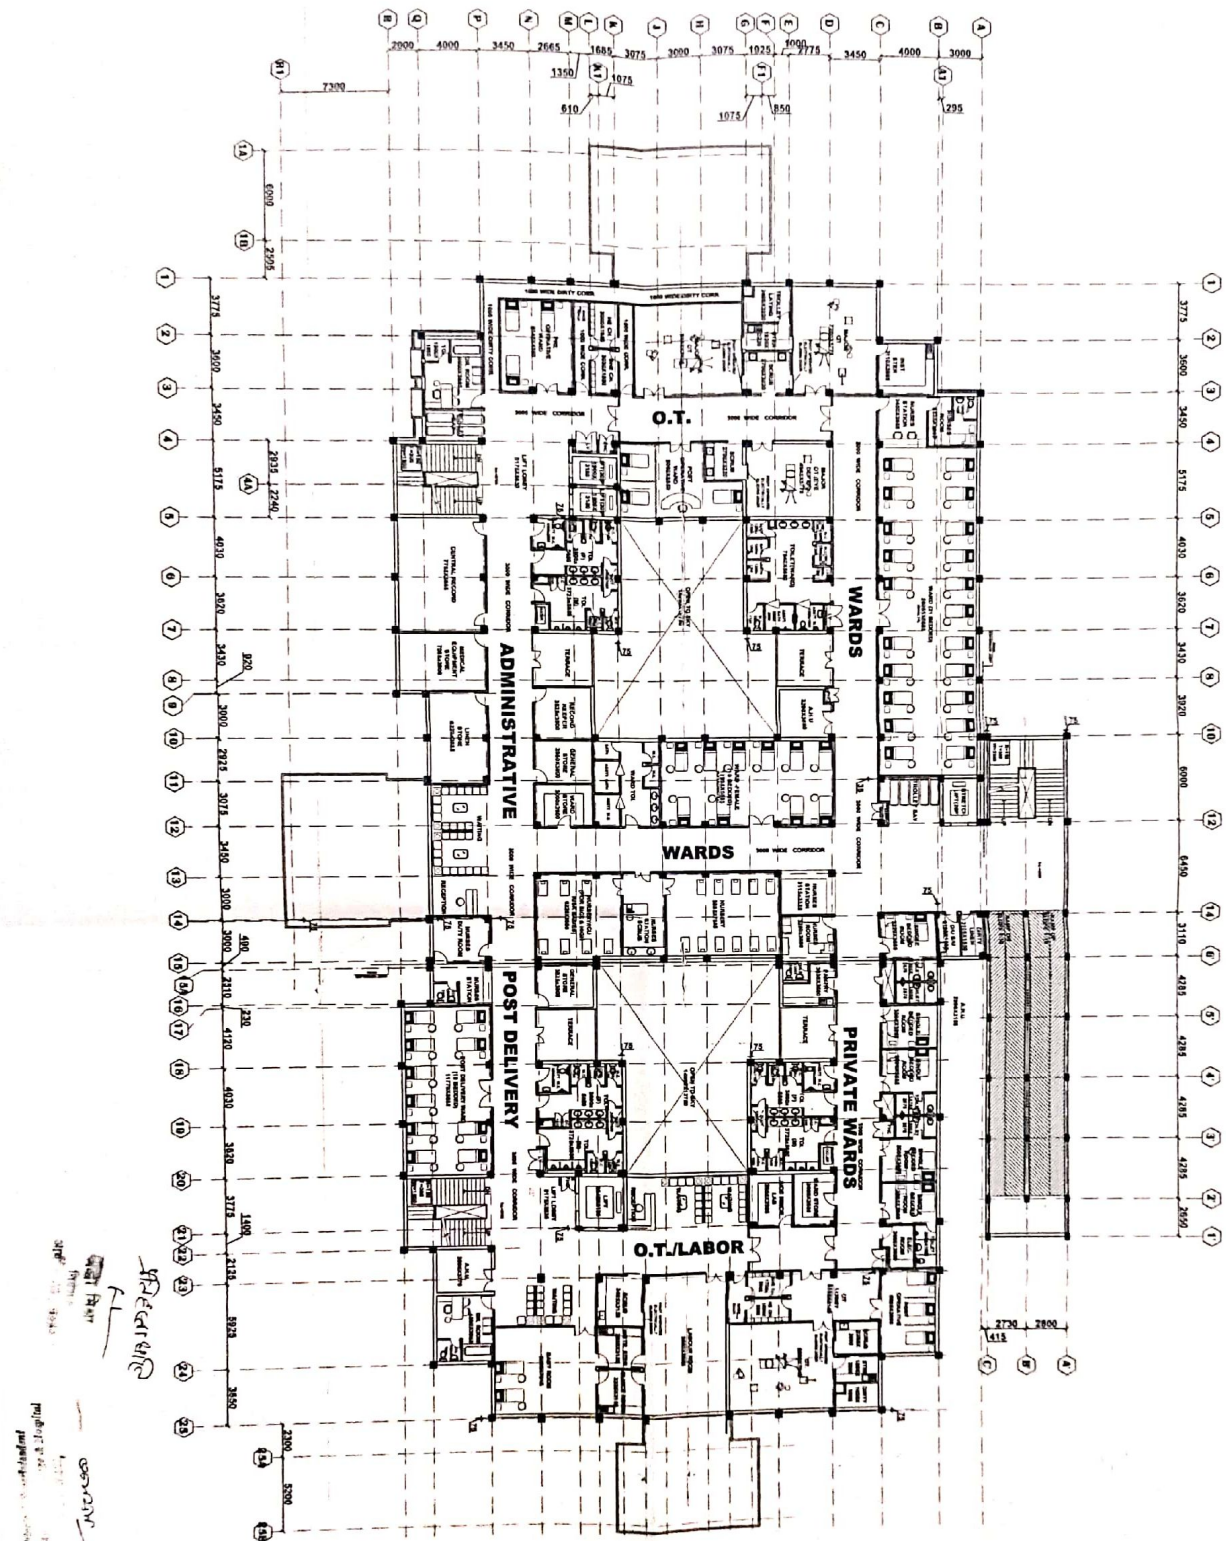

PROPOSED GOVERNMENT AYURVEDIC MEDICAL COLLEGE AT VARANASI	
HOSPITAL BUILDING	
SECOND FLOOR PLAN	
SCALE: 1:150	DATE: OCT. 2010
SHEET No. 03	
CONSULTING ARCHITECT:	
PRODESIGNERS	
Architect: Prashant K. Singh	
Office: 1501, New Town, New Town, Varanasi, U.P. 221002	
For more information, visit our website: www.prodesigners.com	
FOR MORE INFORMATION, VISIT: www.prodesigners.com	
PRO-DESIGNERS, 1501, NEW TOWN, VARANASI, U.P. 221002	